



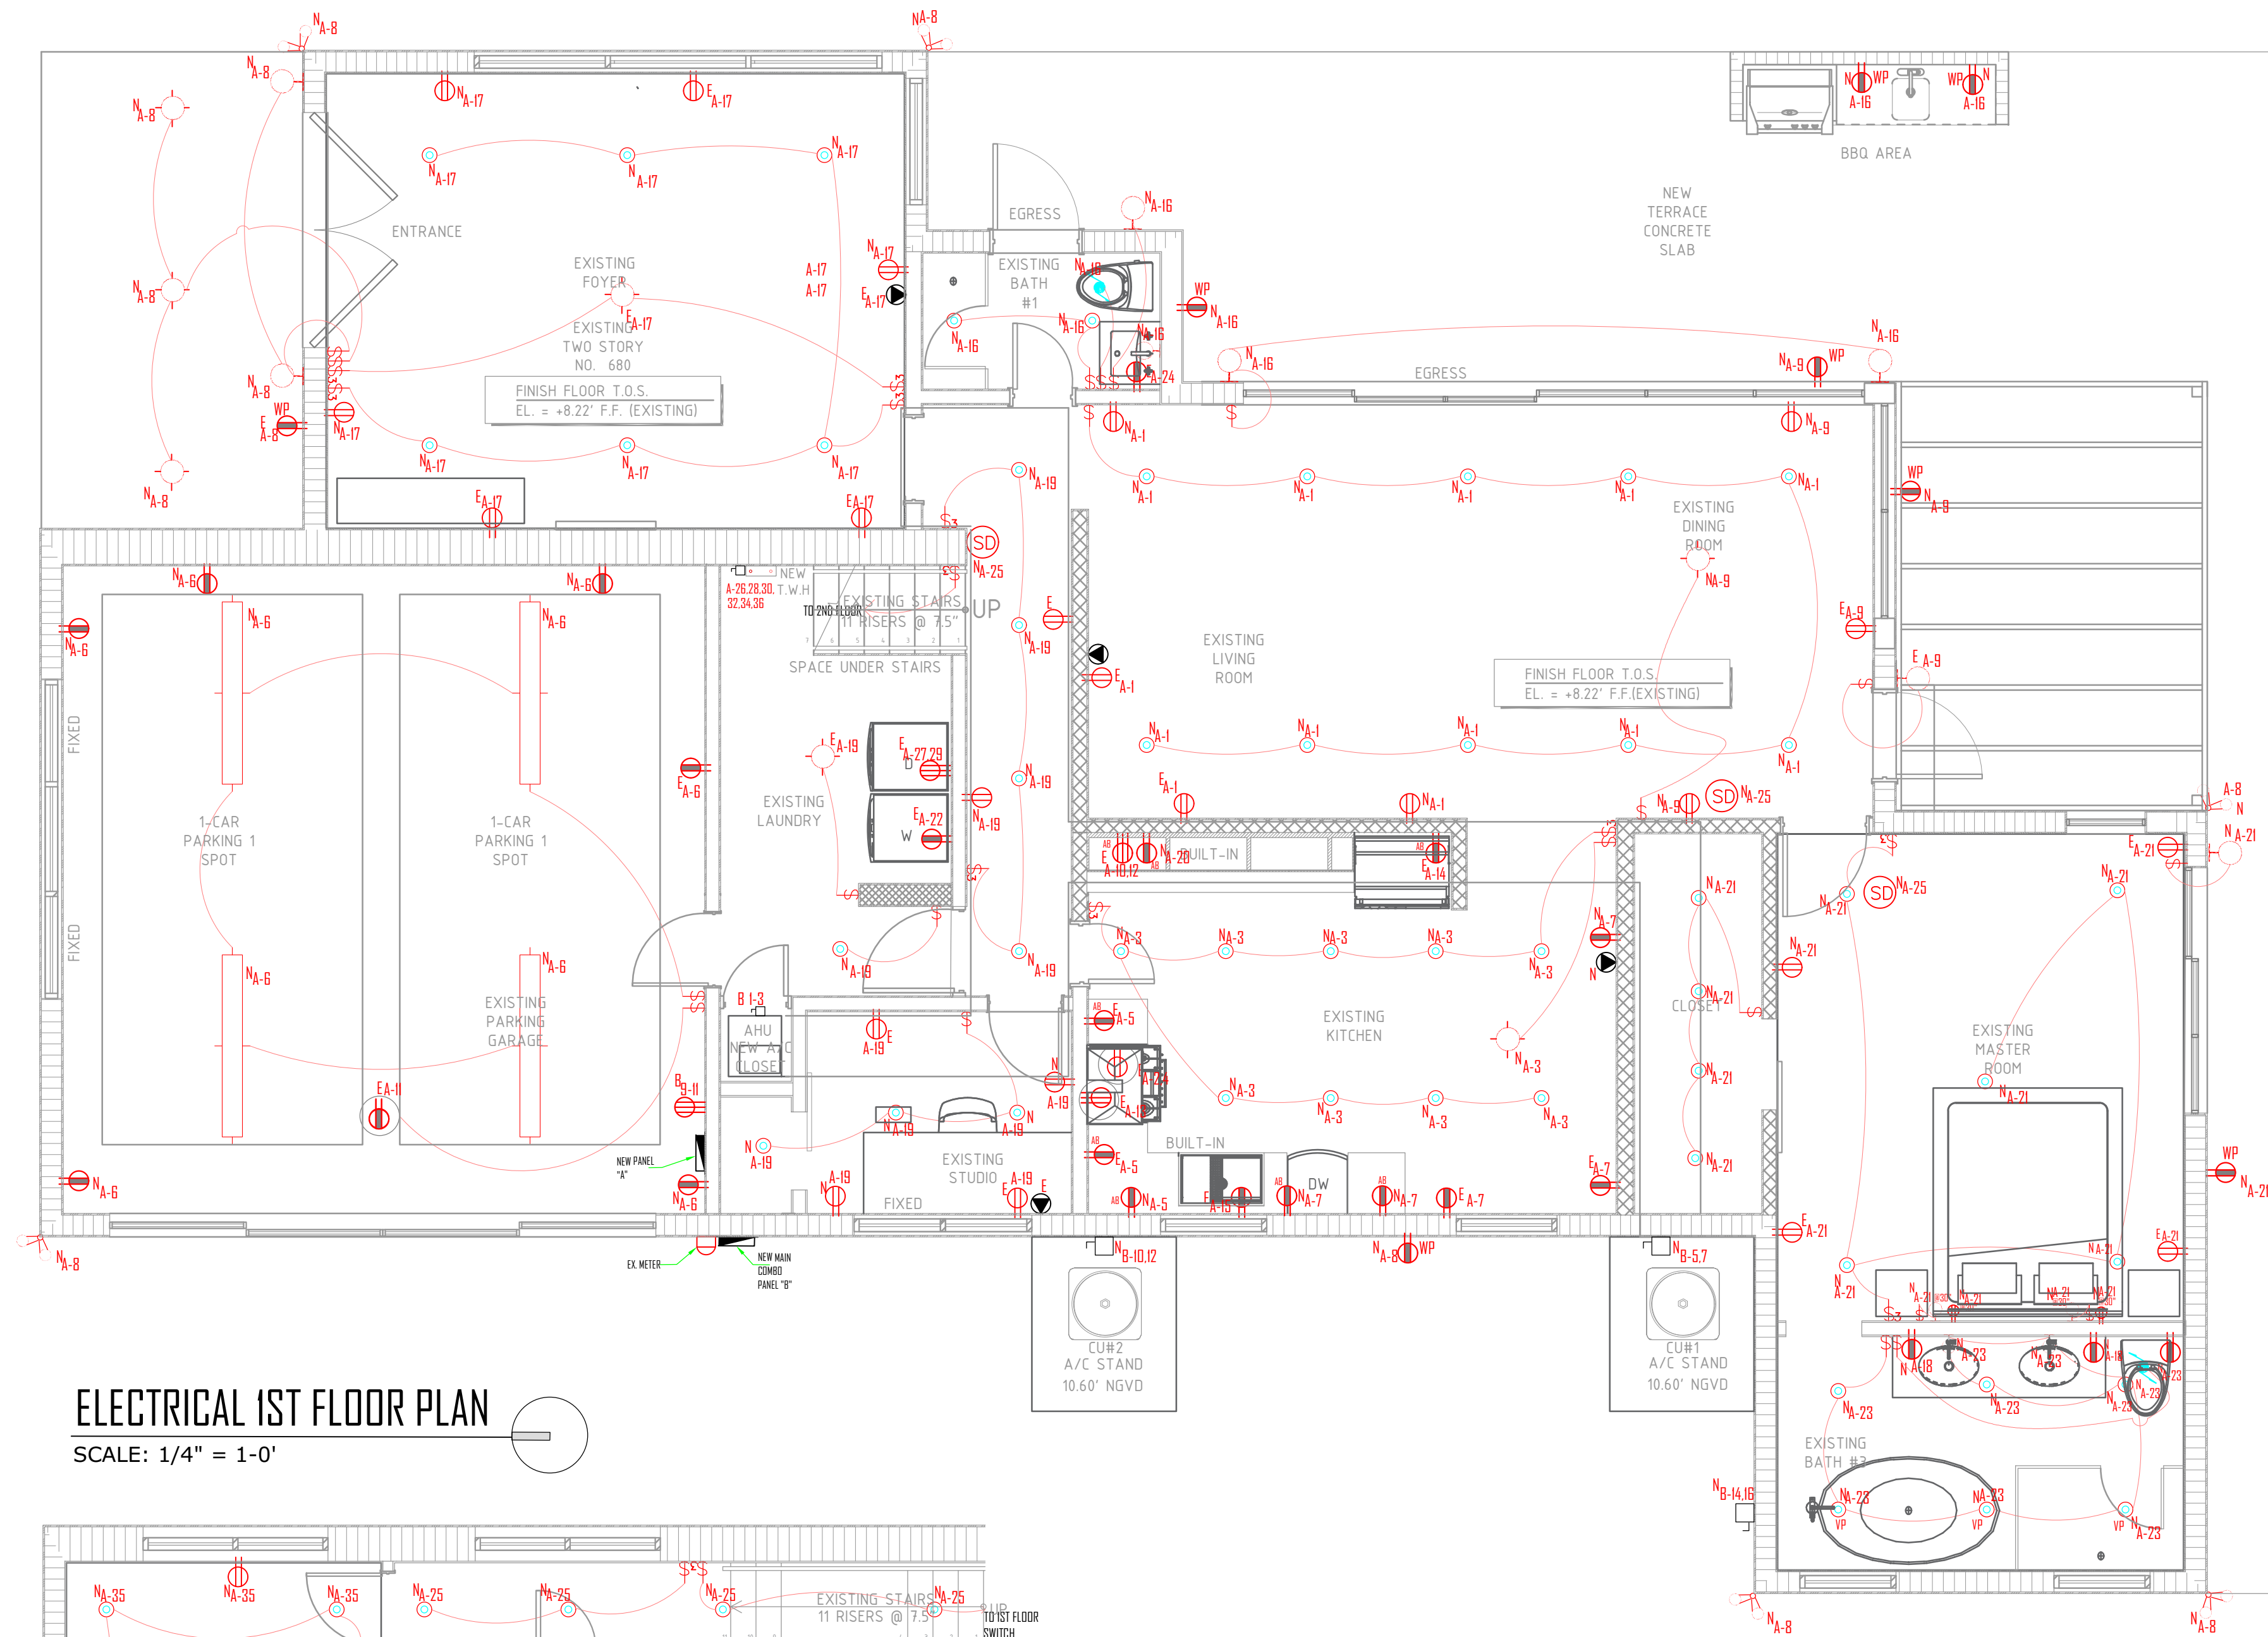

ELECTRICAL 1ST FLOOR PLAN
SCALE: 1/4" = 1'-0"

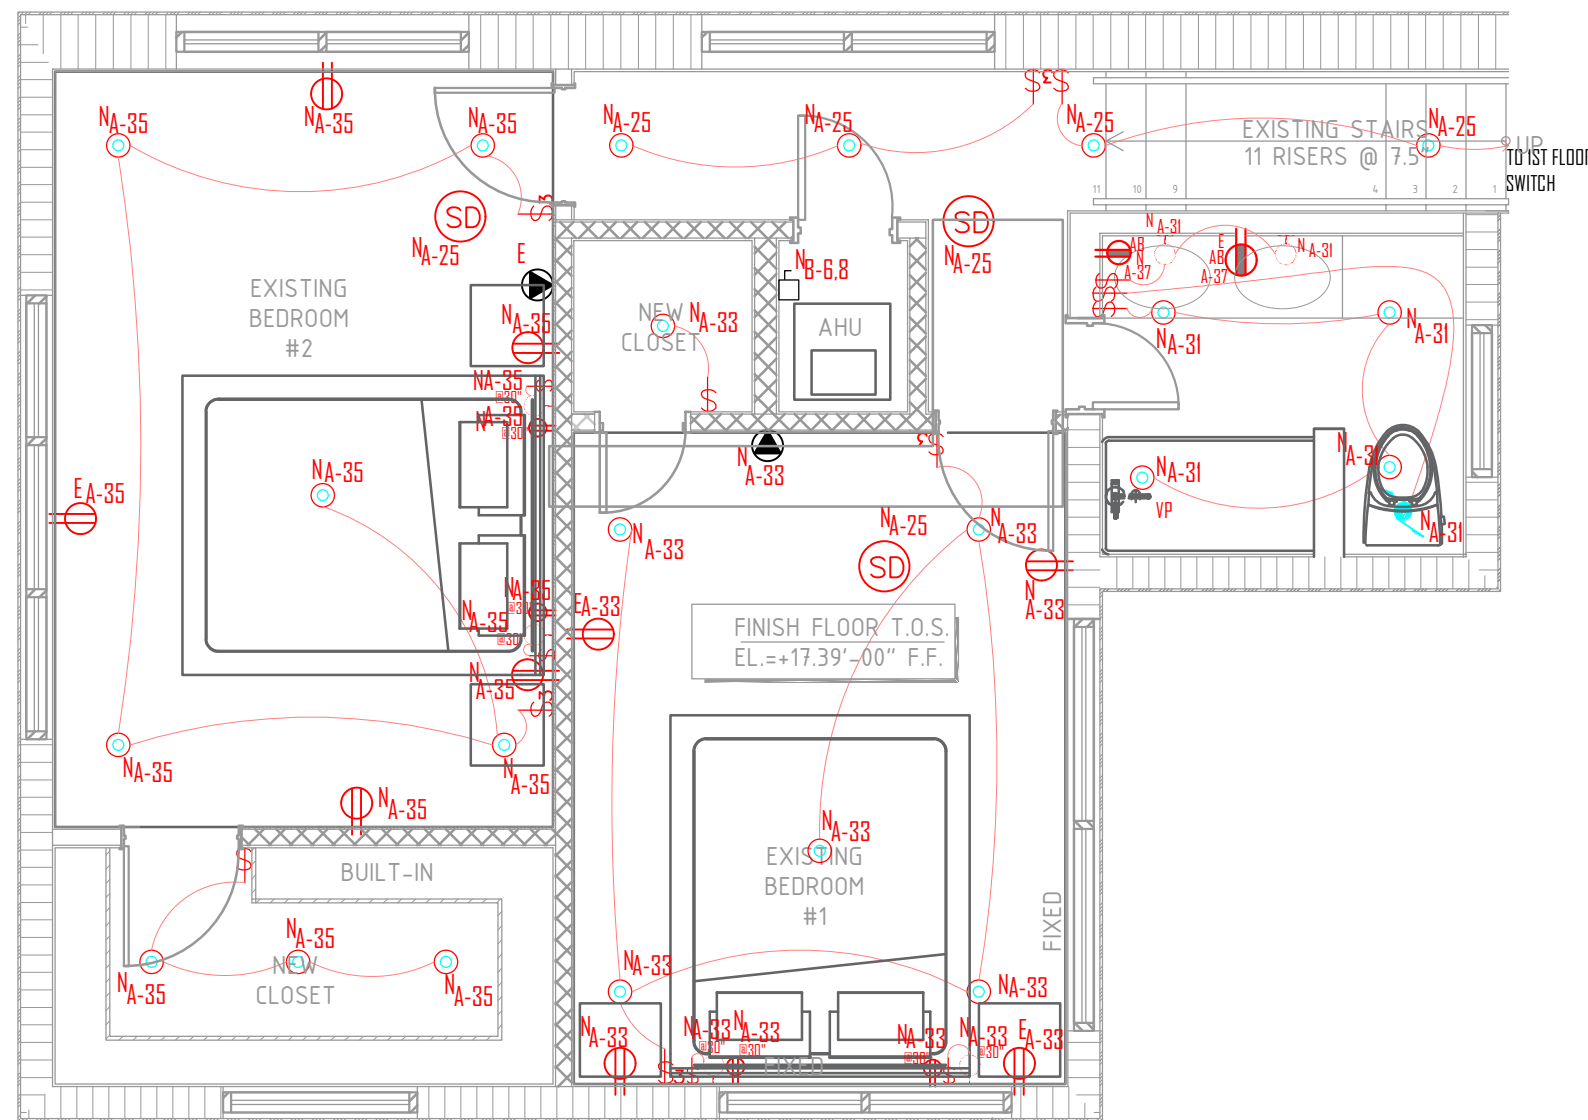

ELECTRICAL 2ND FLOOR PLAN
SCALE: 1/4" = 1'-0"

- LEGEND**
- INCANDESCENT LUMINAIRE, SURFACE MOUNTED.
OR RECESSED HI-HAT TO BE SELECTED.
 - INCANDESCENT LUMINAIRE, WALL MOUNTED.
 - RECESSED HI-HAT
 - FLOOD LIGHTS
 - SINGLE POLE LIGHT SWITCH, QUIET TYPE,
AND DISPOSAL CIRCUITS, INSTALL 48" A.F.F.
 - THREE WAY LIGHT SWITCH, QUIET TYPE,
120 VOLTS, 15 AMPS, INSTALL 48" A.F.F.
 - DEDICATED RECEPTACLE OUTLET, INSTALL
18" A.F.F. UNLESS OTHERWISE INDICATED
 - RECEPTACLE OUTLET
18" A.F.F. UNLESS OTHERWISE INDICATED
 - RECEPTACLE GROUND FAULT CIRCUIT INTERRUPTER
INSTALL 18" A.F.F. UNLESS OTHERWISE INDICATED
 - RECEPTACLE OUTLET @ CEILING
 - 230V DEDICATED RECEPTACLE OUTLET,
INSTALL 18" A.F.F. UNLESS OTHERWISE INDICATED
 - FOURPLEX, FOUR GANG
RECEPTACLE
 - TELEPHONE JACK
 - CABLE T.V. OUTLET
 - AFCI
 - AB
 - WP
 - ELECTRICAL PANEL
 - METER
 - DISCONNECT SWITCH
 - SMOKE/CARBON MONOXIDE DETECTORS COMBO
 - SMOKE/CARBON MONOXIDE DETECTORS COMBO
 - EXHAUST FAN
 - VP
 - E
 - N
 - CEILING MOUNTED FAN W/ OPTIONAL LIGHT
KIT TO BE CHOSEN BY OWNER
 - 6" LED LUMINAIRE



REVISIONS	BY
1 05/12/2023	BLDG.

CESAR CASTILLO, PE
Consulting Engineer - FL Reg # 68447
4908 SW 72nd Ave, Ste. A, Miami, FL 33155
Phone: (954) 803-8968 - ccastillo@paramec.com

**2 STORY RESIDENCE
REMODELING
680 NE 50TH TERRACE,
MIAMI, FL 33137**

**ROBERT LASALLE
680 NE 50TH TERRACE,
MIAMI, FL 33137**

PROFESSIONAL SEAL:
**Cesar
Castillo, PE**
Digitally signed by Cesar Castillo,
PE
DN: c=US, cn=Cesar Castillo, PE,
email=cesarcastillo@gmail.com,
serial=1
Date: 2023.08.14 09:33:26 -0400

LAST DATE REV.:
05-12-2023

ELECTRICAL
PLAN

SHEET: 21 OF 26

E-1