



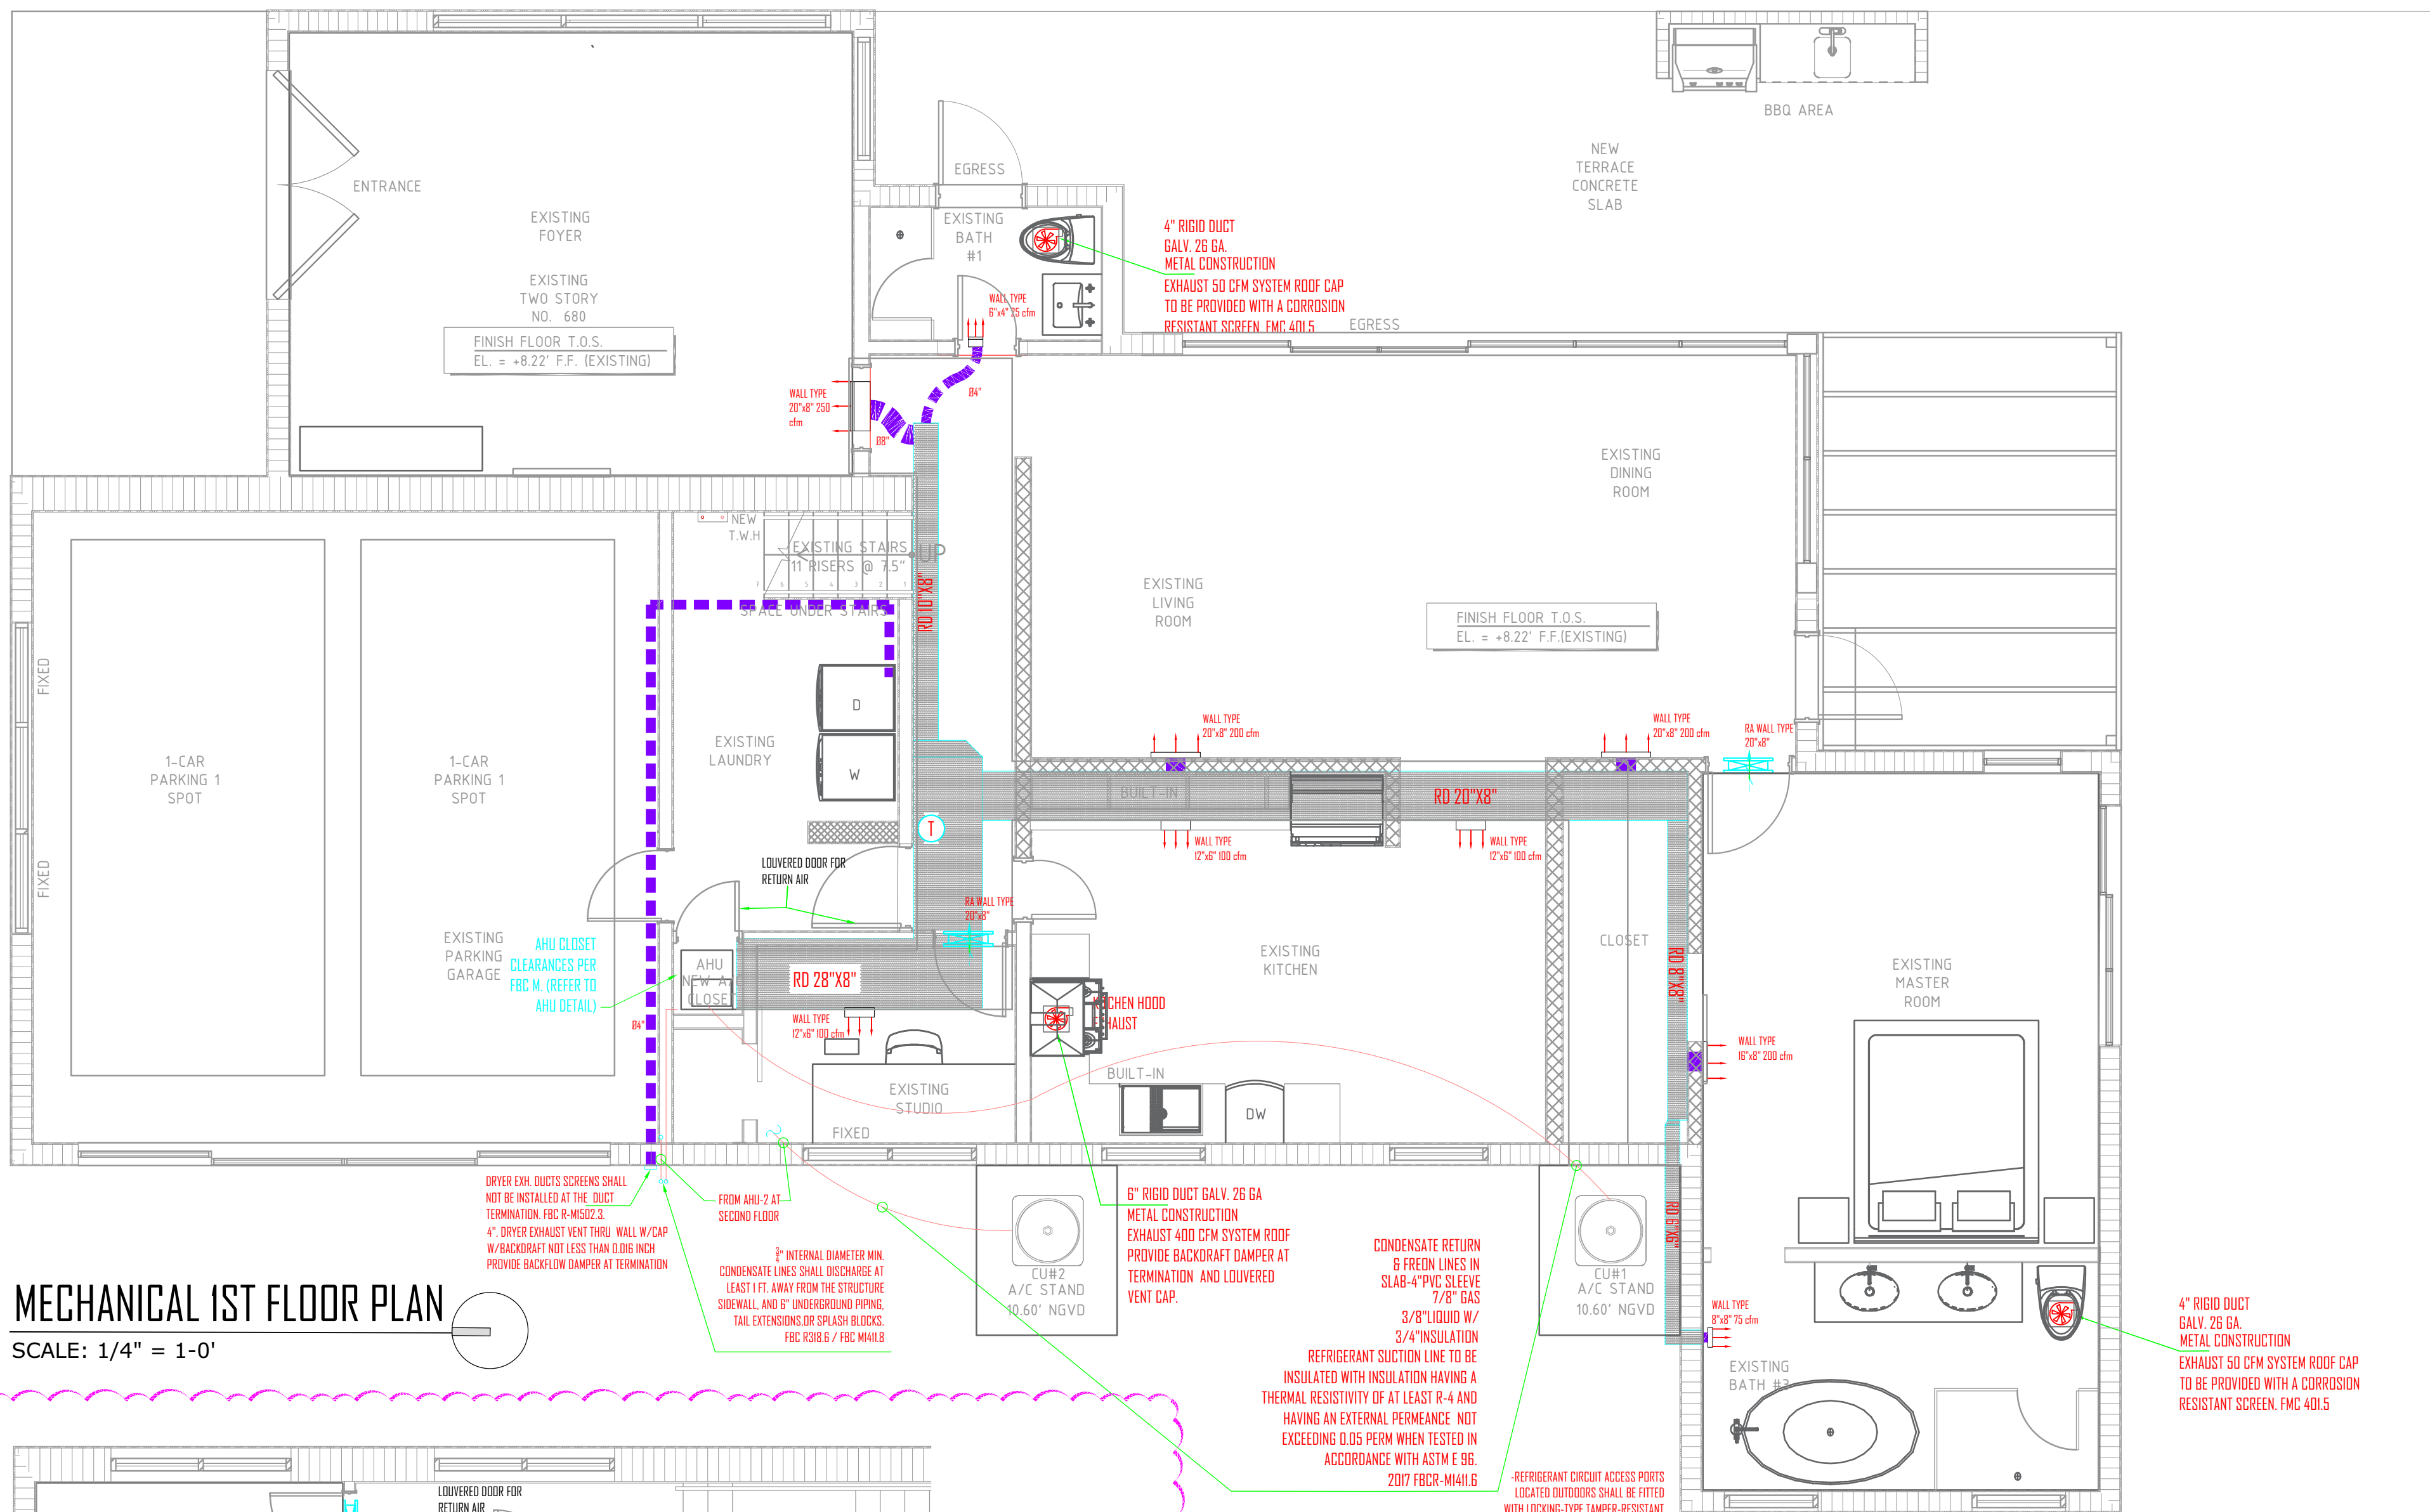

MECHANICAL 1ST FLOOR PLAN

SCALE: 1/4" = 1'-0"

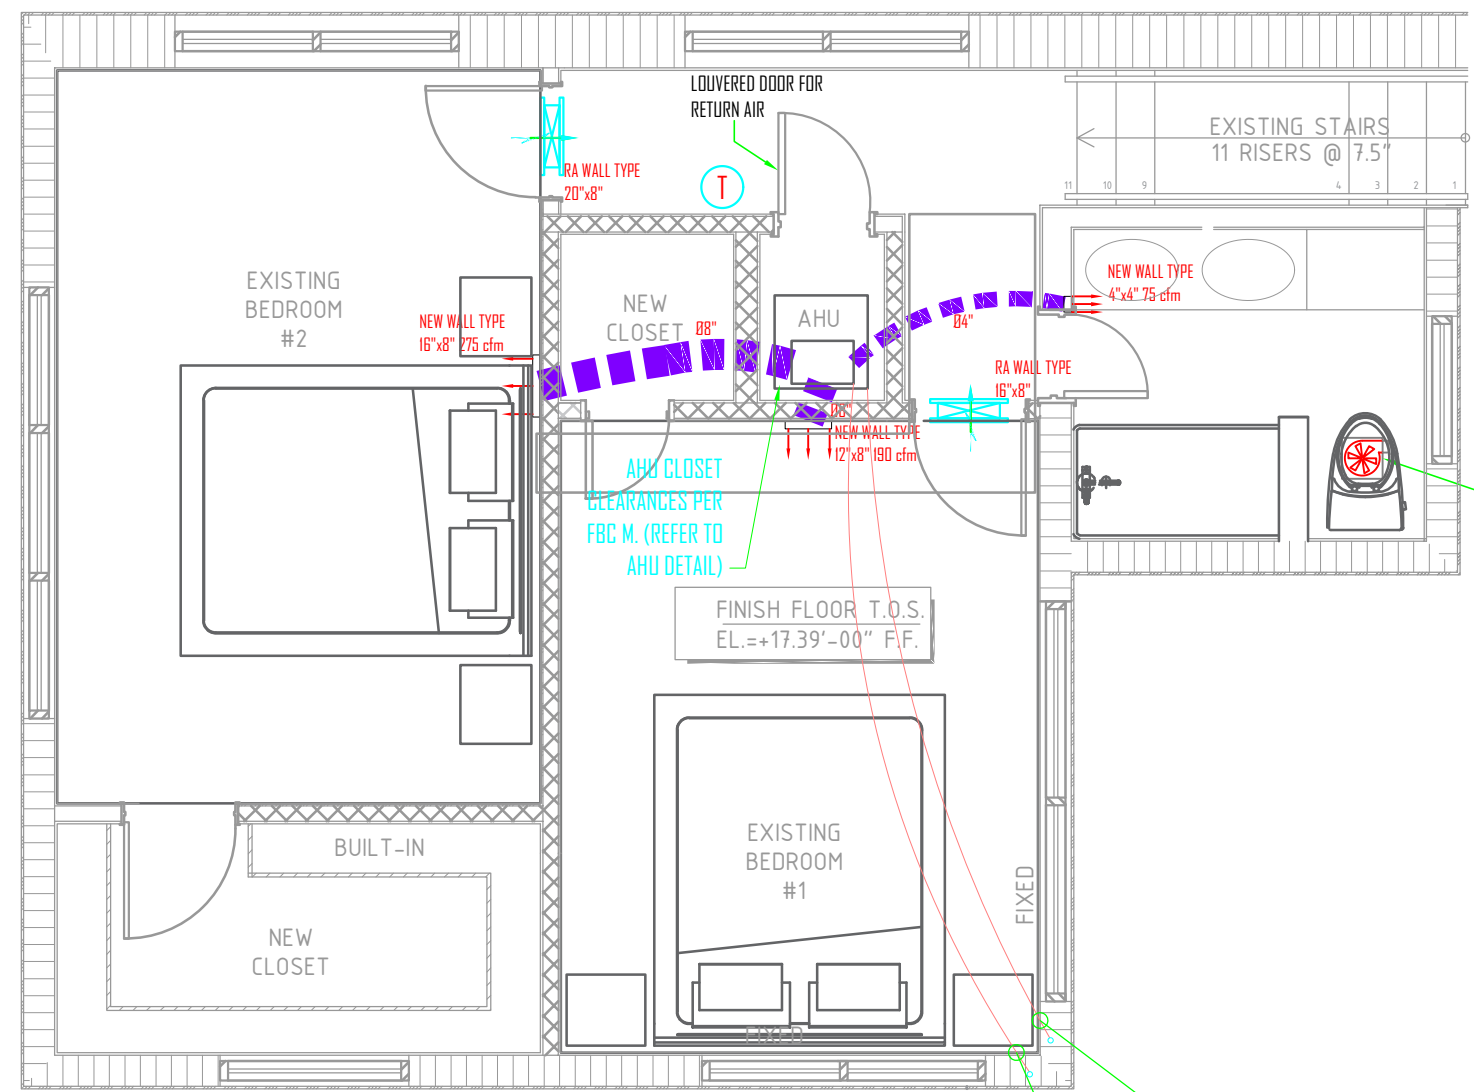

MECHANICAL 2ND FLOOR PLAN

SCALE: 1/4" = 1'-0"

LEGEND

- EVERBILT - HVAC ALUMINUM LAMINATE FLEX DUCT R-8 (ALL SIZES)
- MASTER FLOW - FIBERGLASS DUCT BOARD R-8
- EVERBILT - STEEL RETURN AIR GRILLE (ALL SIZES)
- EVERBILT - STEEL WALL/CEILING GRILLE 1-WAY, 2-WAY OR 4-WAY (ALL SIZES)

REVISIONS	BY
1 05/12/2023	BLDG.

CESAR CASTILLO, PE
Consulting Engineer - FL Reg # 68447
4908 SW 72nd Ave, Ste. A, Miami, FL 33155
Phone: (954) 803-8968 - c.castillo@paramecanic.com

2 STORY RESIDENCE
REMODELING
680 NE 50TH TERRACE,
MIAMI, FL 33137

ROBERT LASALLE
680 NE 50TH TERRACE,
MIAMI, FL 33137

PROFESSIONAL SEAL:

Digitally signed
by Cesar
Castillo, PE
DN: c=US,
cn=Cesar
Castillo, PE,
email=cesarcasti
llopabon@gmail
.com
Date: 2023.08.14
14:37:37 -04'00'

LAST DATE REV.:
05-12-2023

MECHANICAL
PLAN

SHEET: 23 OF 26

M-1